



clwyd theatr cymru

EMLYN WILLIAMS THEATRE

PRODUCTION DETAILS

LAST UPDATE	DRAWN BY	DRAWING No
-------------	----------	------------



PRODUCTION

AUTHOR

DIRECTOR

DESIGNER

LIGHTING BY

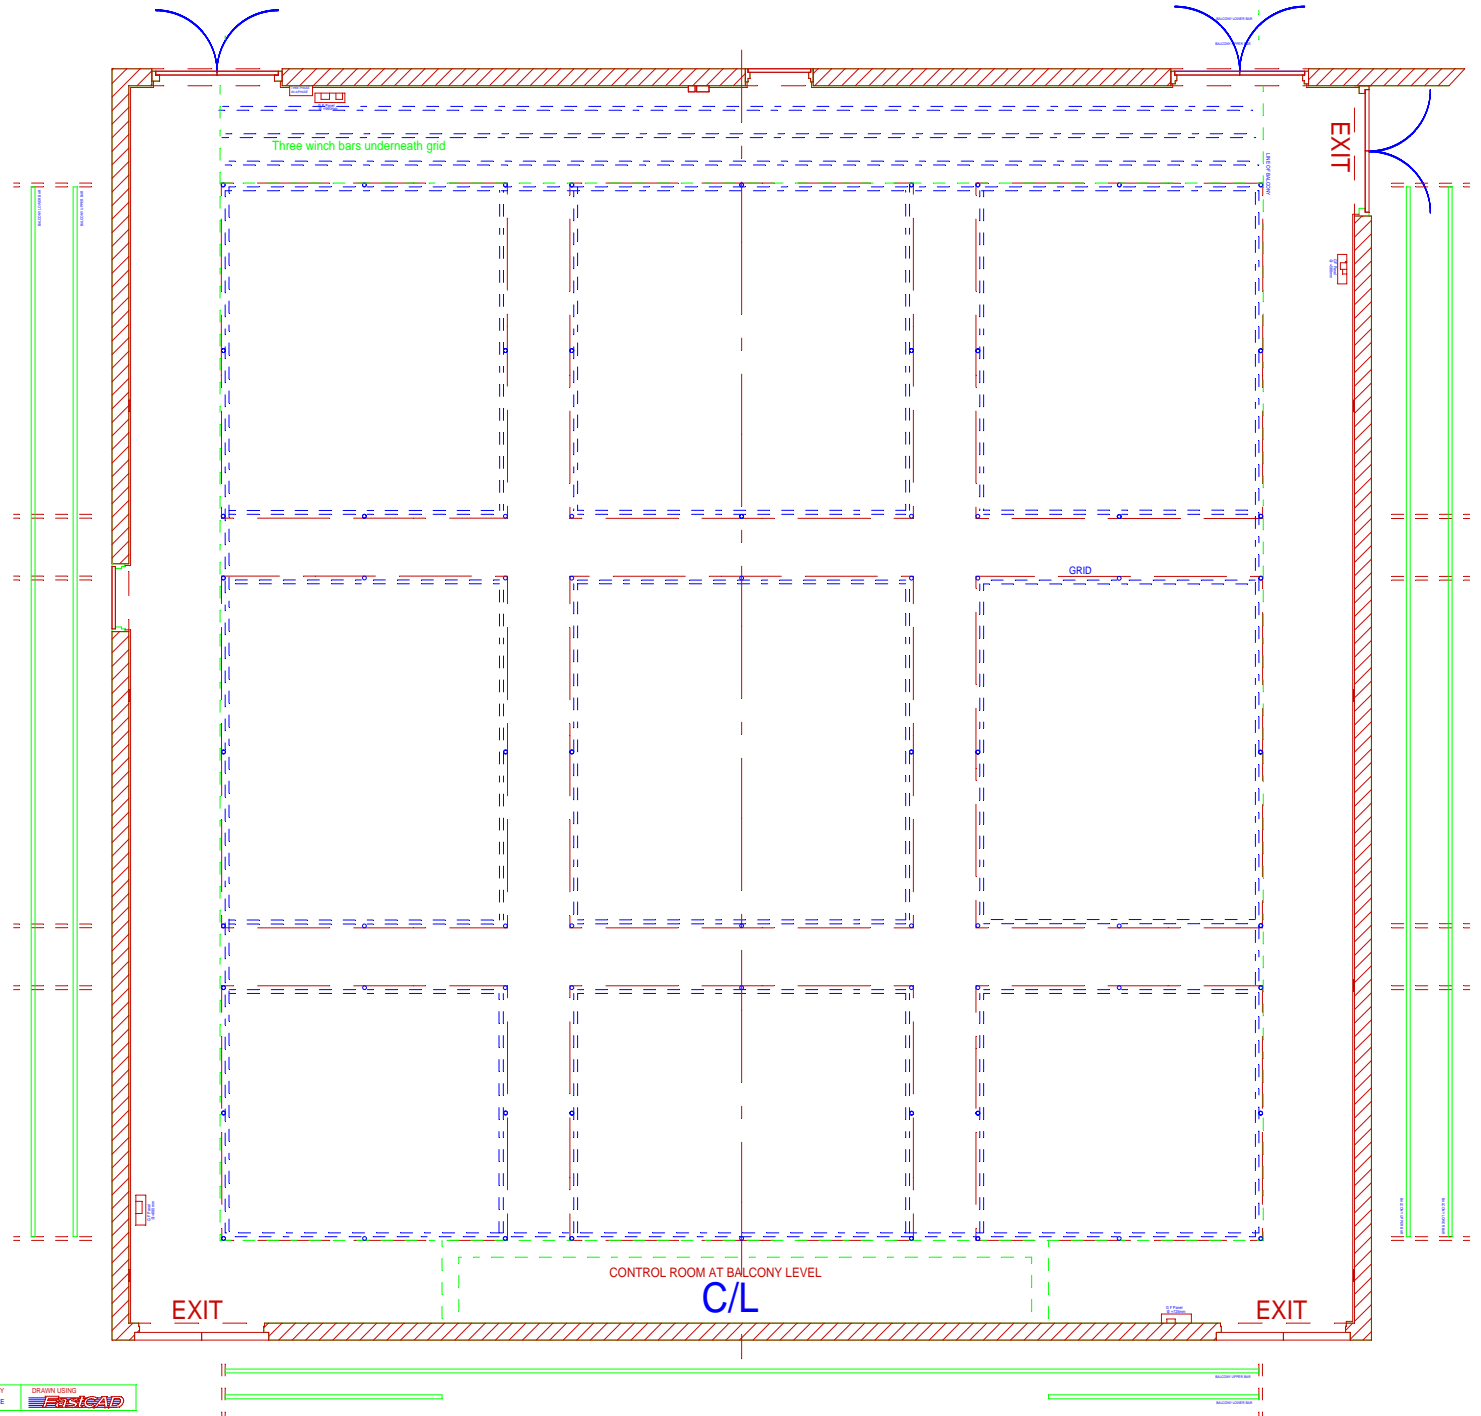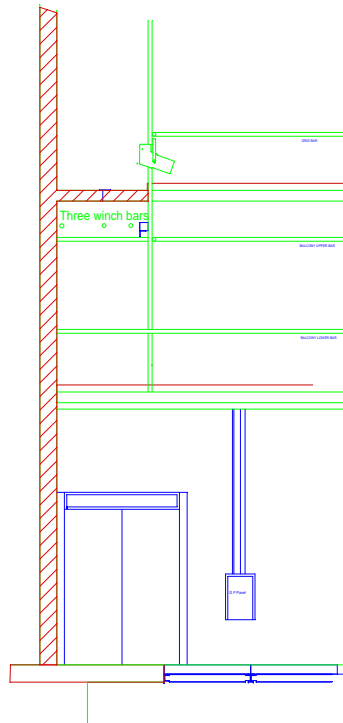

clwyd theatr cymru

EMLYN WILLIAMS THEATRE

GRID / GROUND PLAN

LIGHTING PLAN SCALE 1:25

LAST UPDATE  
23/04/16

DRAWN BY  
HUGH PRICE

DRAWN USING  
AutoCAD